
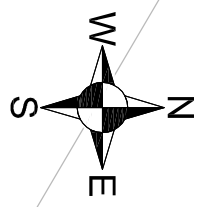


REPRODUCED BY PERMISSION OF ORDNANCE SURVEY ON BEHALF OF HMSO. CROWN COPYRIGHT AND DATABASE RIGHT OS DATA LICENCE EXPIRATION: 19.01.13  
 ALL RIGHTS RESERVED. LICENCE NUMBER AL10012293

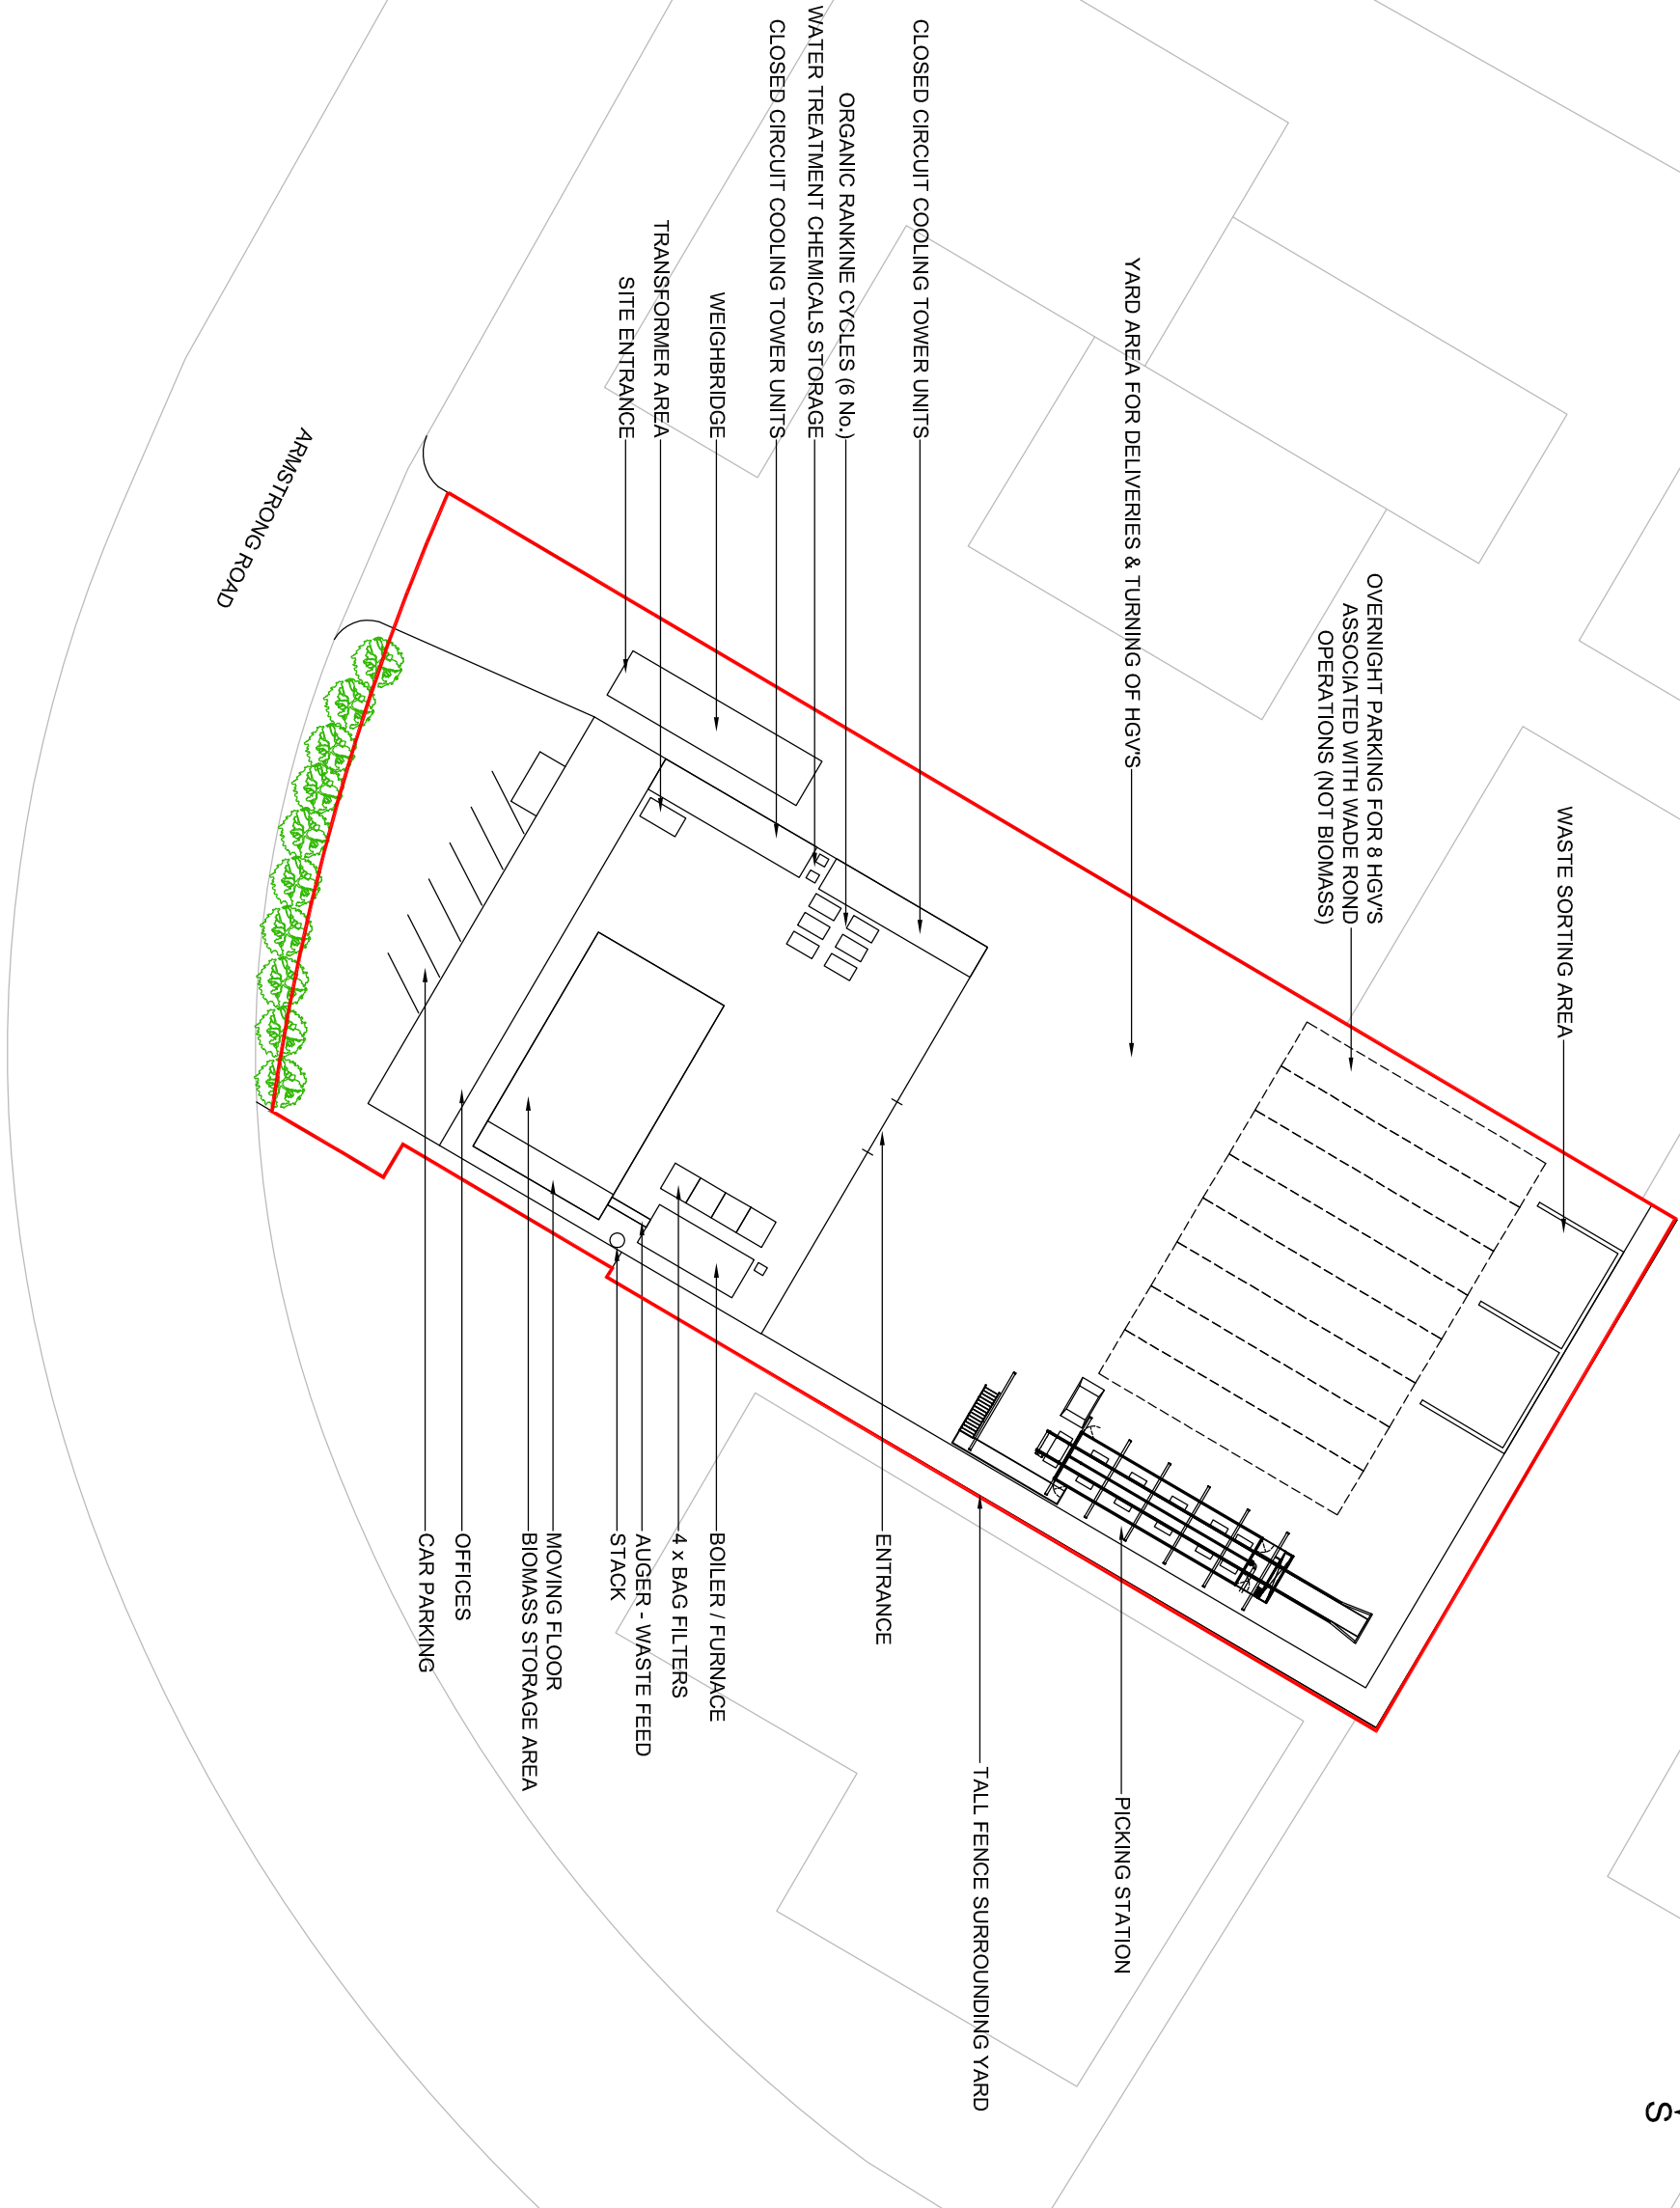

NOTES  
 LOCATIONS ARE INDICATIVE ONLY

LEGEND  
 PLANNING APPLICATION BOUNDARY

0	JD	JC	05.06.13
---	----	----	----------

Basingstoke Skip Hire and Southern Waste Management Ltd

**SLR**  
 TREEWOOD HOUSE  
 ROWDEN LANE  
 BRADFORD-ON-AVON  
 WILTS. BA15 2AU  
 T: 01225 309400  
 F: 01225 309401  
 www.slrconsulting.com

DANESHILL INDUSTRIAL ESTATE  
 COMBINED HEAT AND POWER PLANT  
 PLANNING APPLICATION  
 SITE LAYOUT

002

Scale 1:500 @ A3  
 Date JUNE 2013