
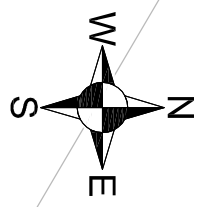


REPRODUCED BY PERMISSION OF ORANGE SURVEY ON BEHALF OF HNSO. CROWN COPYRIGHT AND DATABASE RIGHT OS DATA LICENCE EXPIRATION: 19.01.13 ALL RIGHTS RESERVED. LICENCE NUMBER AL10012293

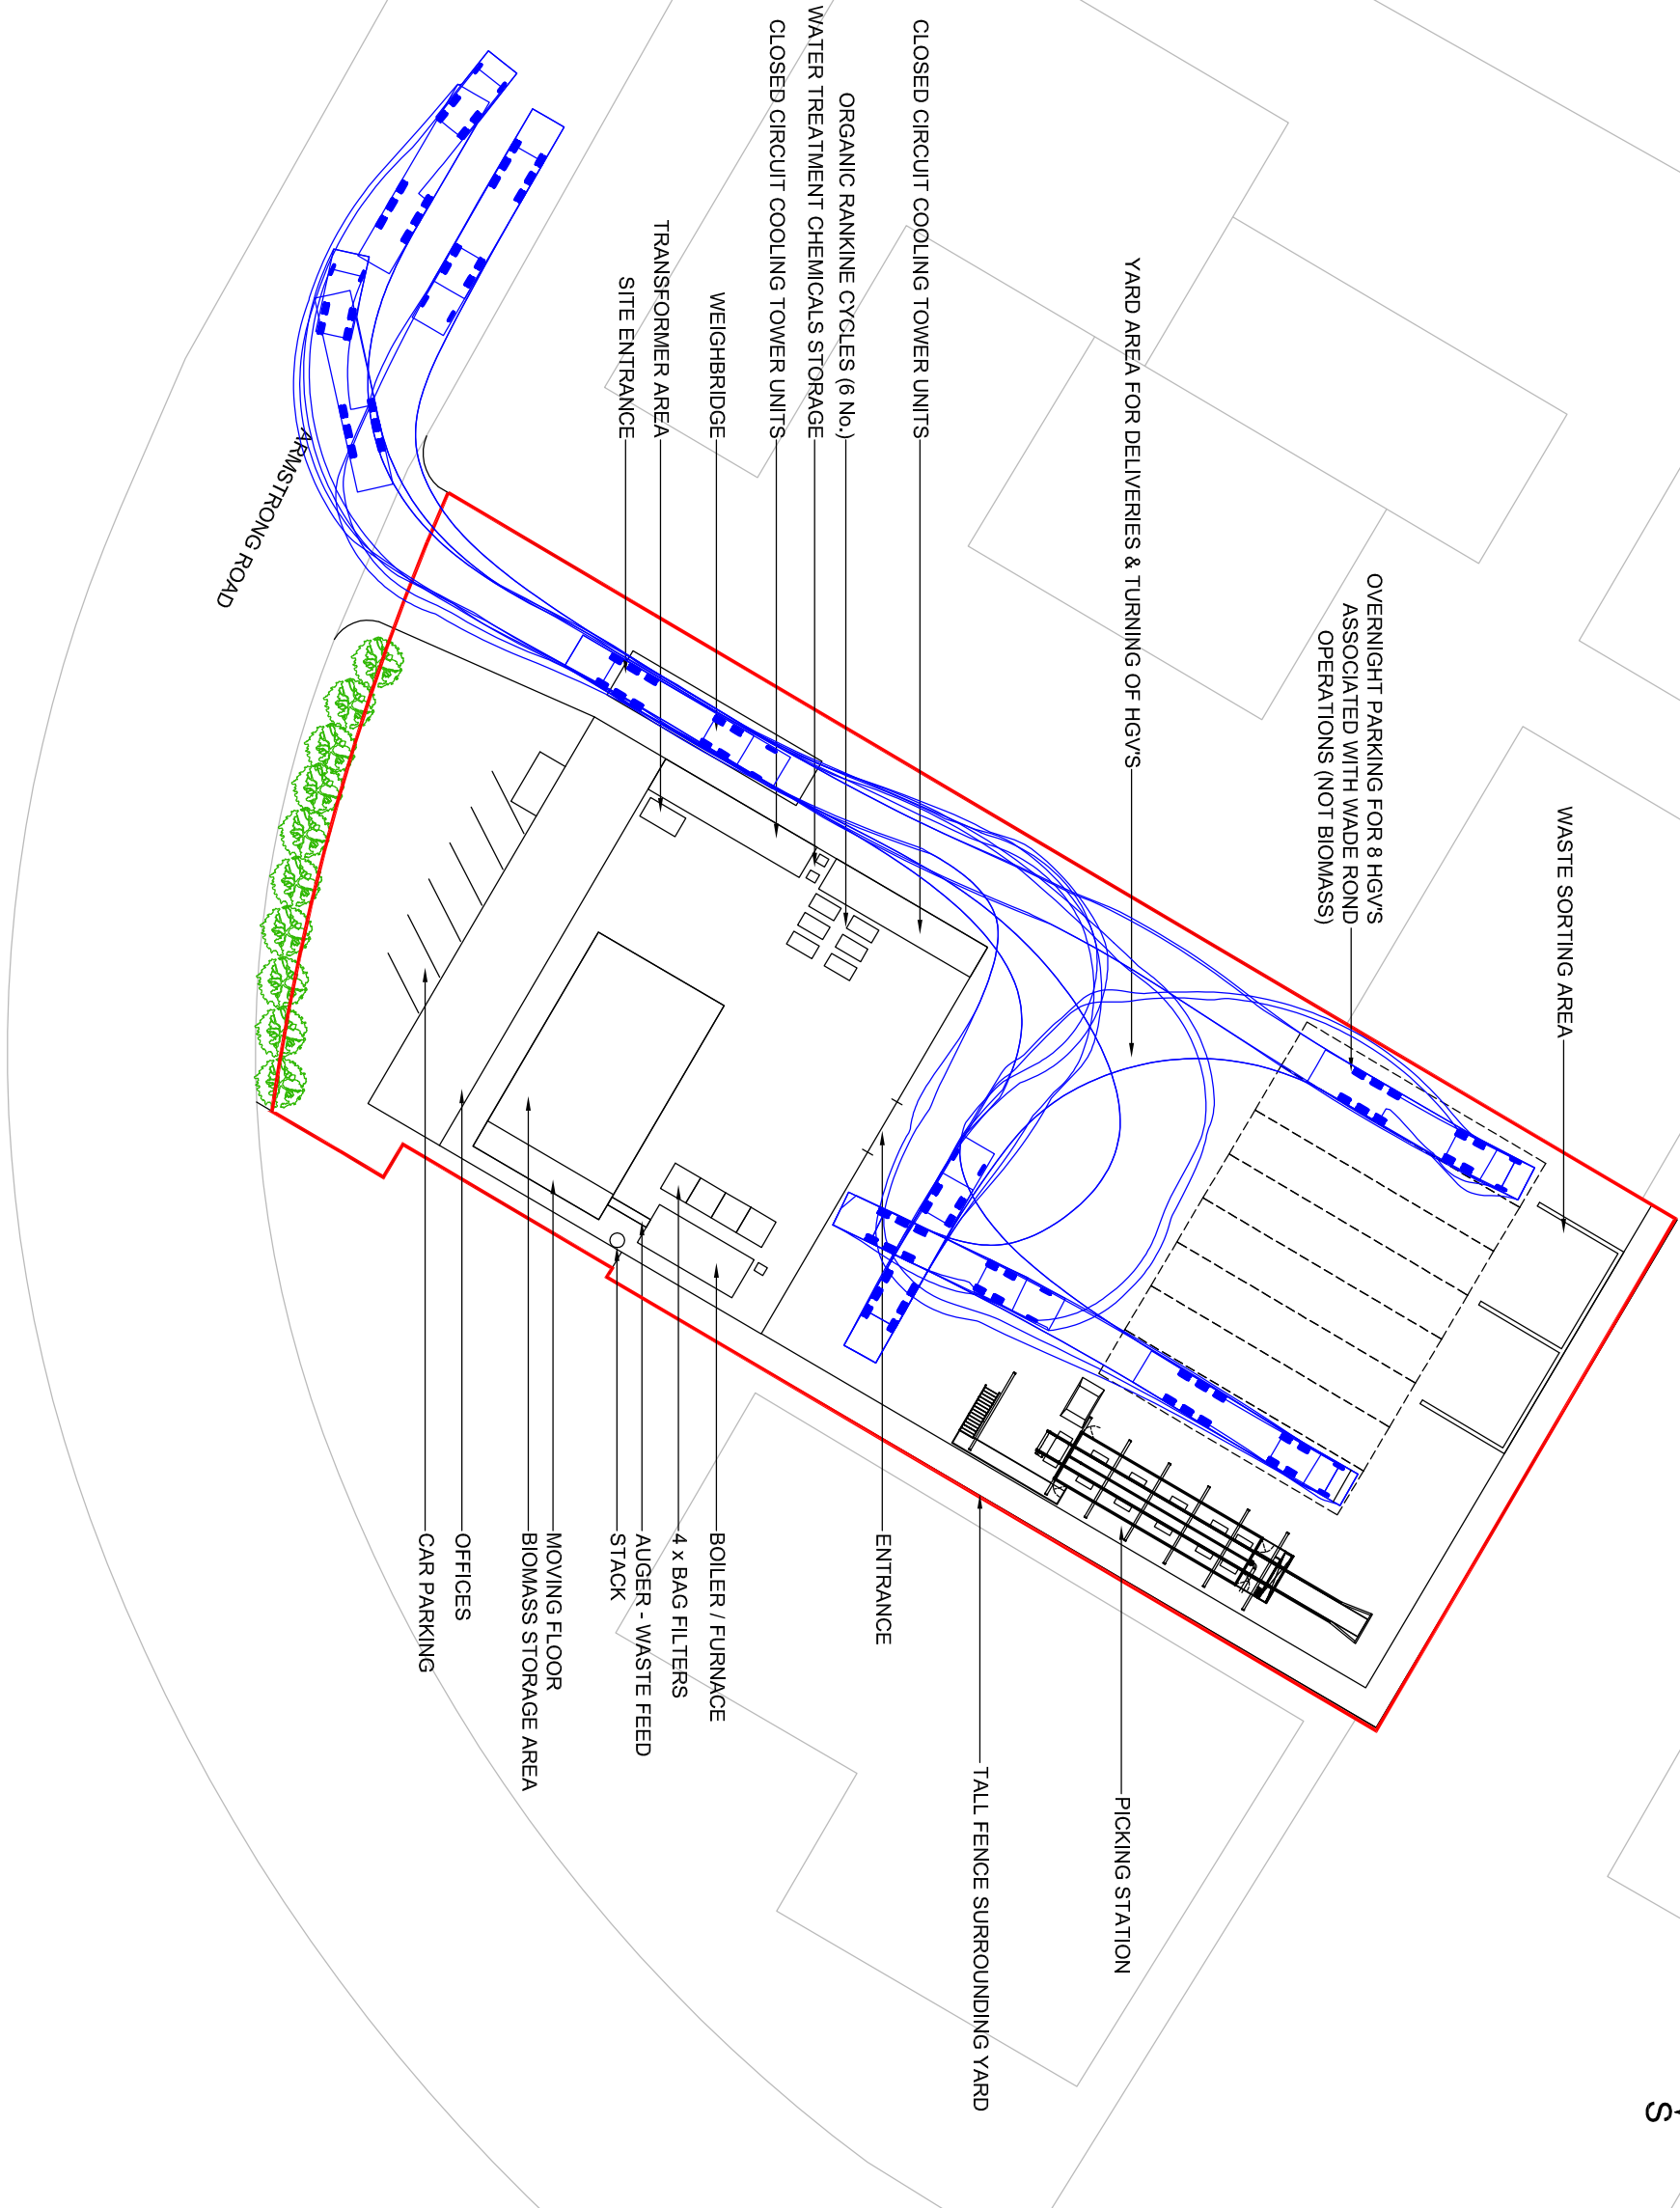

NOTES  
LOCATIONS ARE INDICATIVE ONLY

LEGEND

	PLANNING APPLICATION BOUNDARY
	MAX LEGAL ARTIC (16.5m x 2.5m)

0	JD	JC	05.06.13
---	----	----	----------

Basingstoke Skip Hire and Southern Waste Management Ltd

**SLR**

TREENWOOD HOUSE  
ROWDEN LANE  
BRADFORD-ON-AVON  
WILTS. BA15 2AU  
T: 01225 309400  
F: 01225 309401  
www.slrconsulting.com

DANESHILL INDUSTRIAL ESTATE  
COMBINED HEAT AND POWER PLANT  
PLANNING APPLICATION  
SITE LAYOUT - VEHICLE TRACKING

003

Scale 1:500 @ A3 Date JUNE 2013