


NOMINAL HEIGHT OF COLUMN (ABOVE G.L.)	BRACKET PROJECTION MAXIMUM (IF APPLICABLE)	PLANTING DEPTH (MINIMUM)	HEIGHT OF DOOR BASE FROM GROUND	MAXIMUM LANTERN		B.S. 5649 'K' FACTOR
				WEIGHT Kg	WINDAGE m ²	
8 METRE DOUBLE	0.5m SPAN	1200mm	300mm	10 (x TWO)	0.10 (x TWO)	1.8
10 METRE DOUBLE	0.5m SPAN	1500mm	300mm	10 (x TWO)	0.11 (x TWO)	1.8
12 METRE DOUBLE	0.5m SPAN	1700mm	500mm	10 (x TWO)	0.11 (x TWO)	1.8

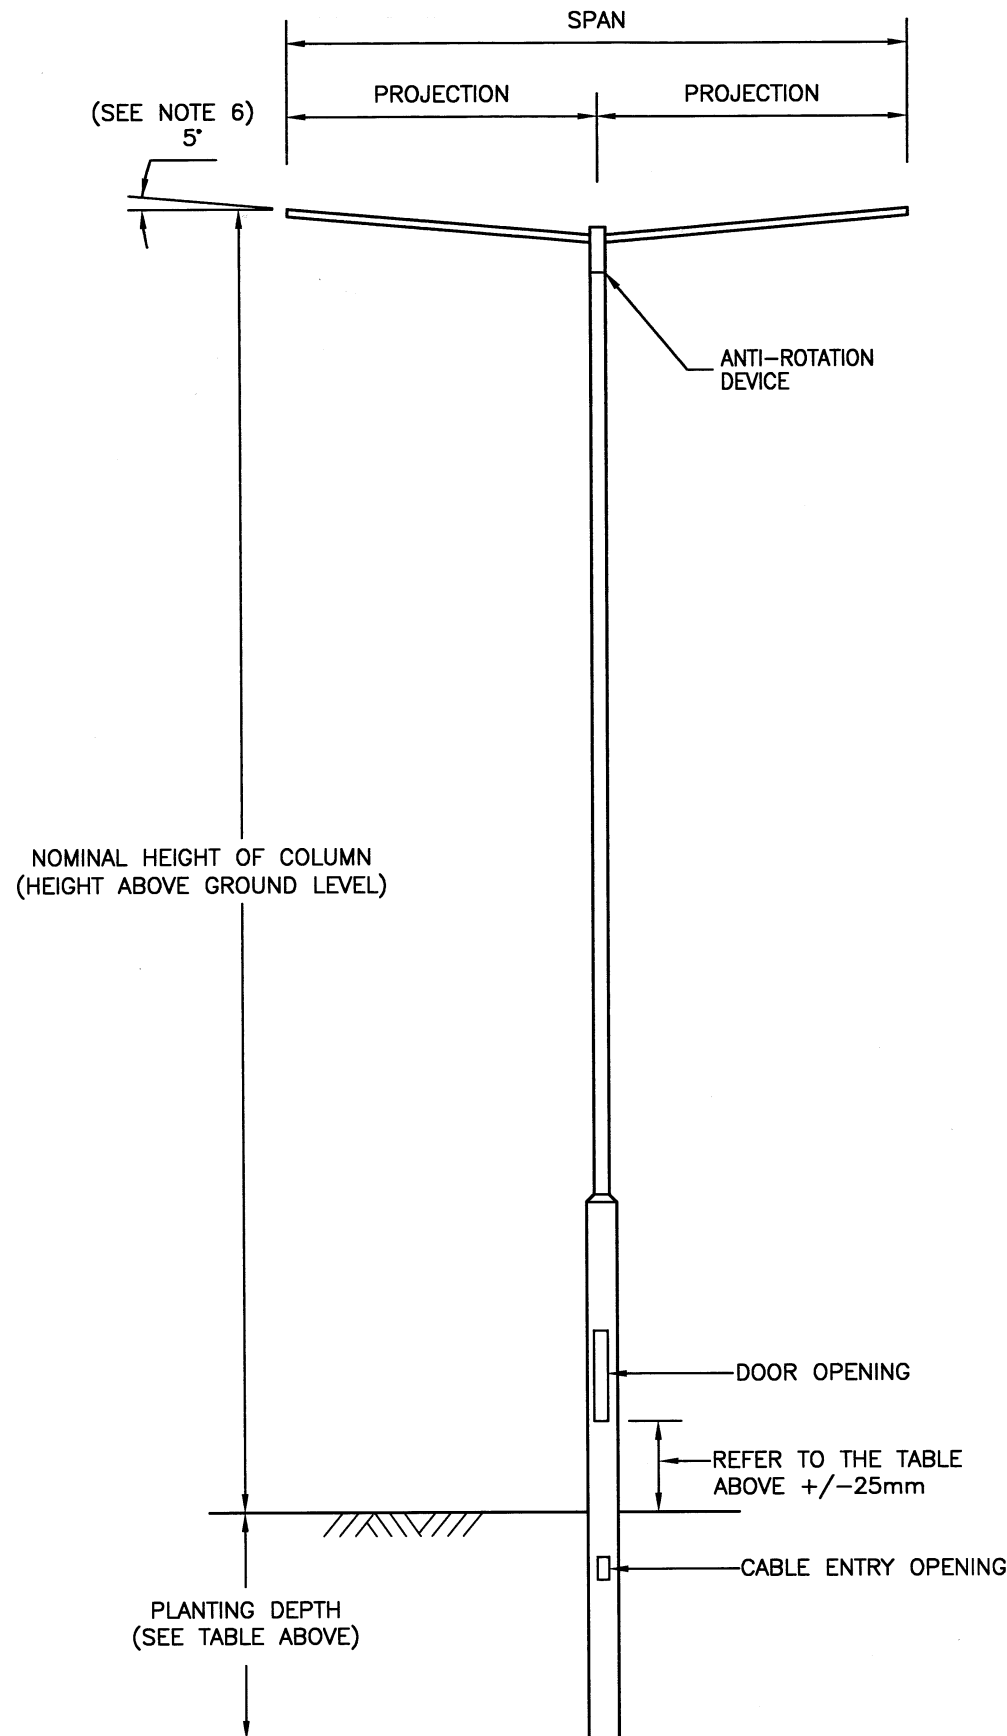

- DOOR OPENING - 600x115
- CABLE ENTRY OPENING - 150x75
- LANTERN MOUNTING - 42/48 DIA SIDE ENTRY
- SPIGOTS - TBC BY MANUFACTURER
- COLUMN NUMBER - 2500 ABOVE GROUND LEVEL ON THE OPPOSITE SIDE OF THE COLUMN TO THE DOOR OPENING

NOTES:

1. ALL DIMENSIONS ARE IN MILLIMETRES.
2. FOR DETAILS OF LOCATIONS OF STREET LIGHTING COLUMNS, SEE STREET LIGHTING LAYOUT DRAWINGS.
3. COLUMNS SHALL COMPLY WITH PD6547:2004+A1:2009 AND THE DEPARTMENTAL STANDARD BD 94/07 IN ADDITION TO THE HCC COLUMN SPECIFICATION, WHICH MUST BE READ IN CONJUNCTION WITH THIS DRAWING.
4. ANY DAMAGE TO THE EQUIPMENT DURING INSTALLATION OR BEFORE ACCRUAL ONTO THE COUNTY'S INVENTORY MUST BE REPAIRED TO A SATISFACTORY STANDARD IN ACCORDANCE WITH THE GUIDELINES GIVEN BY THAT SPECIFIC MANUFACTURER FOR ITS SPECIFIC FINISH OR COATING.
5. ALL DUCTING AND CABLES SHALL BE LAID IN ACCORDANCE WITH THE CURRENT EDITION OF NJUG IN CONJUNCTION WITH THE CURRENT EDITION OF HAUC (UK) GUIDANCE.
6. LANTERNS SHALL HAVE A MAXIMUM TILT OF 5°.
7. ANY DEVIATION FROM THE LISTED COLUMN WEIGHT AND/OR WINDAGE MUST BE REFERRED BACK TO THE MANUFACTURER FOR ADDITIONAL GUIDANCE AND MUST BE RECORDED.
8. DOORS TO BE SECURED BY STAINLESS STEEL M8 ANTI-VANDAL DOOR BOLTS WITH HEXAGONAL HEAD COMPLETE WITH INTEGRAL CENTRE PIN, CAPABLE OF BEING OPERATED ONLY WITH SPECIAL HEXAGONAL KEY WITH CENTRE HOLE TO ACCEPT PIN LOCATION.

REV	AMENDMENTS	DATE	CAD	CHKD	APPD
-	-	-	-	-	-

CONSULTANT

STUART JARVIS BSc DipTP FCIHT MRTPI: DIRECTOR OF ECONOMY, TRANSPORT & ENVIRONMENT

SCHEME

STANDARD DETAILS

DRAWING TITLE

**COLUMN TYPE 2B
TUBULAR STEEL
PLANTED COLUMNS**

HCC CADplot: 30.Nov.2015 at 2:27pm		SCALE @ A3
DRAWN	CHECKED	N.T.S
WW	IH	
CAD	APPROVED	DATE
WW	CP	July 2015
DRG No.	REVISION	
HCC10/L/020	-	

Copyright Hampshire County Council. 2015

All rights, including translation, reserved. No part of this publication may be reproduced, stored in a retrieval system, or transmitted in any form or by any means (electronic, mechanical, photocopied, recorded or otherwise) without the prior written permission of Hampshire County Council. Requests should be directed to the Economy, Transport & Environment Department.

**DOUBLE BRACKET
COLUMN TYPE 2B**