



TYPICAL FRONT VIEW OF FEEDER PILLAR

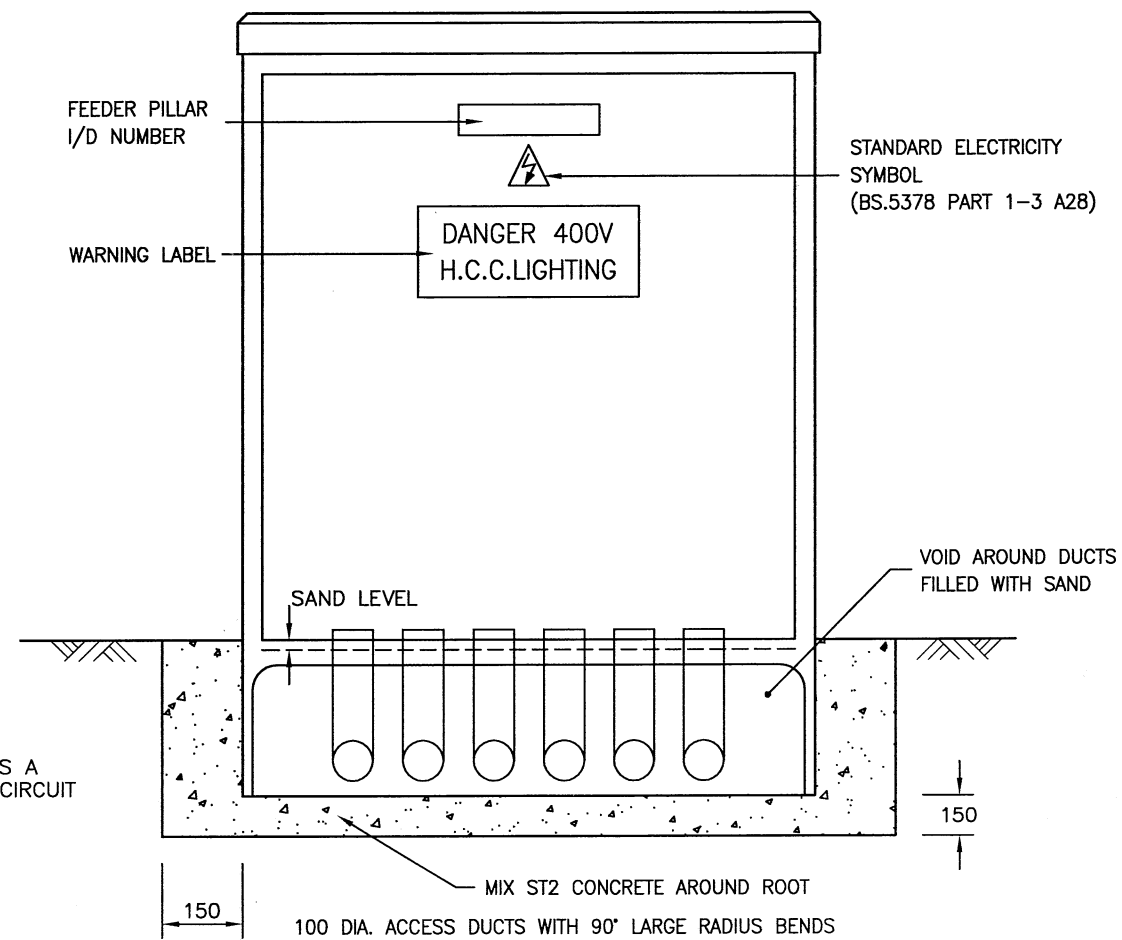

FEEDER PILLAR FOUNDATION DETAIL

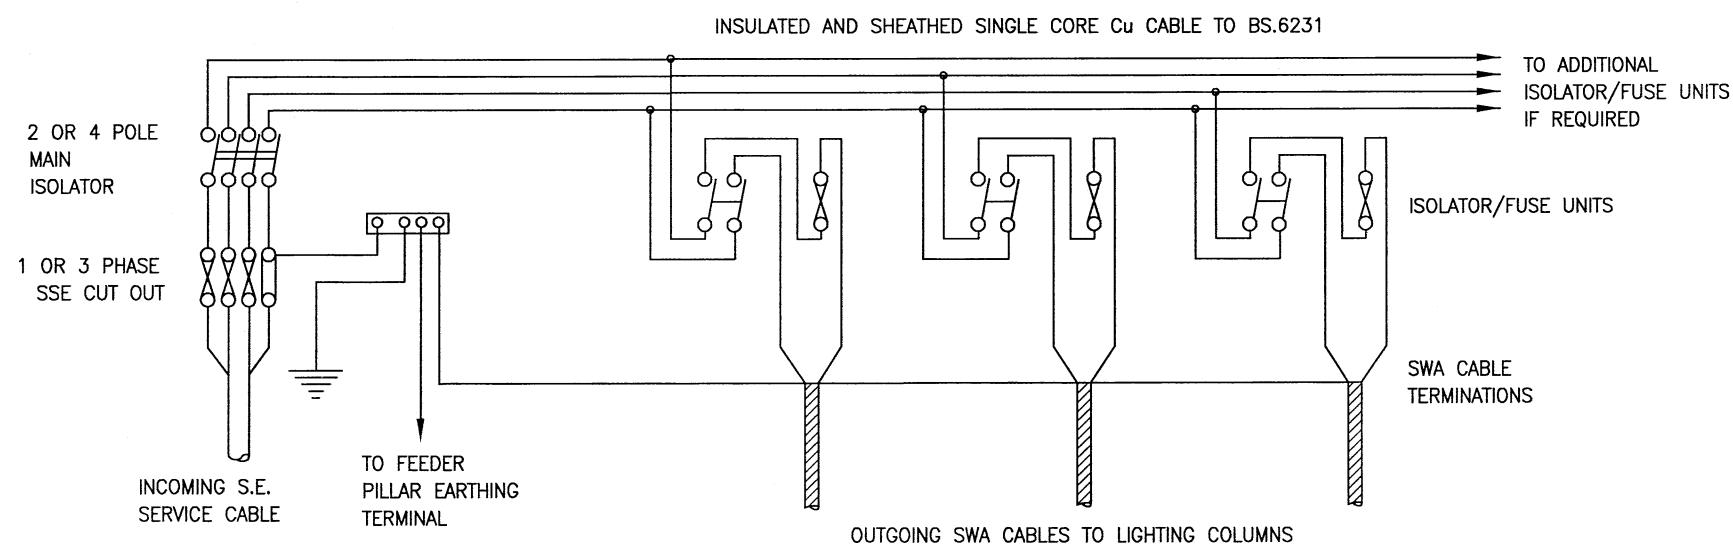

TYPICAL WIRING LAYOUT

NOTES:

1. ALL DIMENSIONS ARE IN MILLIMETRES.
2. FOR LOCATION OF FEEDER PILLARS, SEE STREET LIGHTING LAYOUT DRAWINGS.
3. A MINIMUM OF 1m² OF HARD STANDING SHALL BE PROVIDED AT GROUND LEVEL IMMEDIATELY IN FRONT OF THE PILLAR DOOR.

REV	AMENDMENTS	DATE	CAD	CHKD	APPD

CONSULTANT

STUART JARVIS BSc DipTP FCIBT MRTPI: DIRECTOR OF ECONOMY, TRANSPORT & ENVIRONMENT

SCHEME

STANDARD DETAILS

DRAWING TITLE

GENERAL FEEDER PILLAR DETAILS

HCC CADplot: 10.Sep.2015 at 1:05pm		SCALE @ A3
DRAWN	CHECKED	SCALE @ A3
RB	IH, IH	N.T.S
CAD	APPROVED	DATE
RB	CP	July 2015
DRG No.	REVISION	
HCC10/L/090	-	

Copyright Hampshire County Council. 2015

All rights, including translation, reserved. No part of this publication may be reproduced, stored in a retrieval system, or transmitted in any form or by any means (electronic, mechanical, photocopied, recorded or otherwise) without the prior written permission of Hampshire County Council. Requests should be directed to the Economy, Transport & Environment Department.