



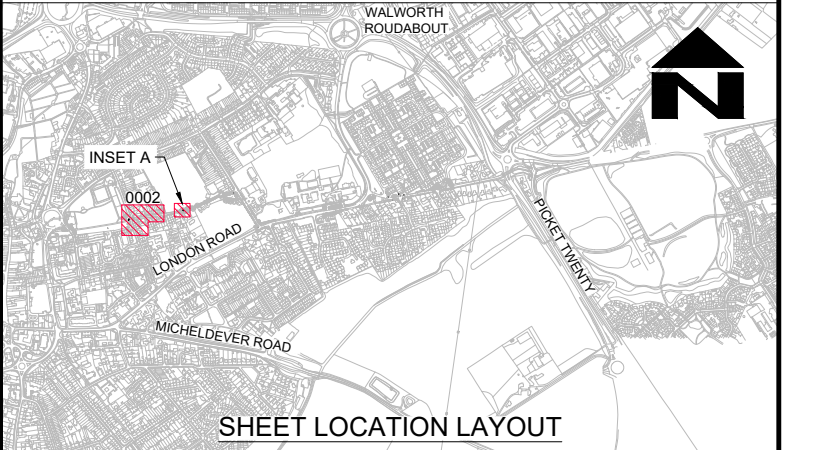

- NOTES**
- DO NOT SCALE FROM THIS DRAWING.
 - ALL DIMENSIONS IN METRES UNLESS OTHERWISE STATED.
 - FOR MORE DETAIL THIS DRAWING SHALL BE READ IN CONJUNCTION WITH DRAWINGS WITH RELEVANT VOLUME CODE
- HSC - SITE CLEARANCE
HDG - DRAINAGE LAYOUT, COVERS AND IRONWORK
HKF - KERBS, FOOTWAYS AND PAVED AREAS
HPV - PAVEMENT DETAILS
VUT - EXISTING UTILITIES
HSE - LONG SECTIONS AND CROSS SECTIONS
HEW - EARTHWORKS
HLG - STREET LIGHTING
HFE - FENCING DETAILS
HTS - PROPOSED TRAFFIC SIGNS AND ROAD MARKINGS
4. REFRESHED ROAD MARKINGS ARE NOT SHOWN.

- KEY**
- EXISTING HIGHWAY BOUNDARY
 - PROPOSED HIGHWAY BOUNDARY
 - PROPOSED BUFF COLOURED TACTILE BLISTER PAVING TO STANDARD DETAIL HCC11/C/060
 - PROPOSED BUFF COLOURED CORDUROY PAVING 400mm x 400mm TO STANDARD DETAIL HCC11/C/045
 - PB# PROPOSED BOLLARD
 - RELOCATED LIGHTING COLUMN
 - EXISTING CARRIAGEWAY TO BE RESURFACED
 - PROPOSED FOOTWAY CONSTRUCTION / RECONSTRUCTION
 - PROPOSED GRASSED VERGE/TOPSOIL & SEED REINSTATEMENT, REGRADED WHERE TADPOLES SHOWN.
 - PROPOSED PRECAST CONCRETE KERB
 - REUSED / ADDITIONAL BOW TOP RAILINGS
 - PG# PROPOSED GULLY
 - EG# EXISTING GULLY GRATING REPLACED WITH D400 COVER. COVER RAISED TO SUIT PROPOSED FOOTWAY LEVEL.
 - EXISTING COVERS/GRATINGS TO BE ADJUSTED
 - EXISTING CHAMBER TO BE RELOCATED BY OPENREACH
 - PS# PROPOSED SIGN
 - BS# RELOCATED BUS STOP
 - ES# REUSED SIGN
 - NP# RELOCATED ROAD NAME PLATE
 - PROPOSED WHITE COLOURED ROAD MARKING
 - PROPOSED YELLOW COLOURED ROAD MARKING

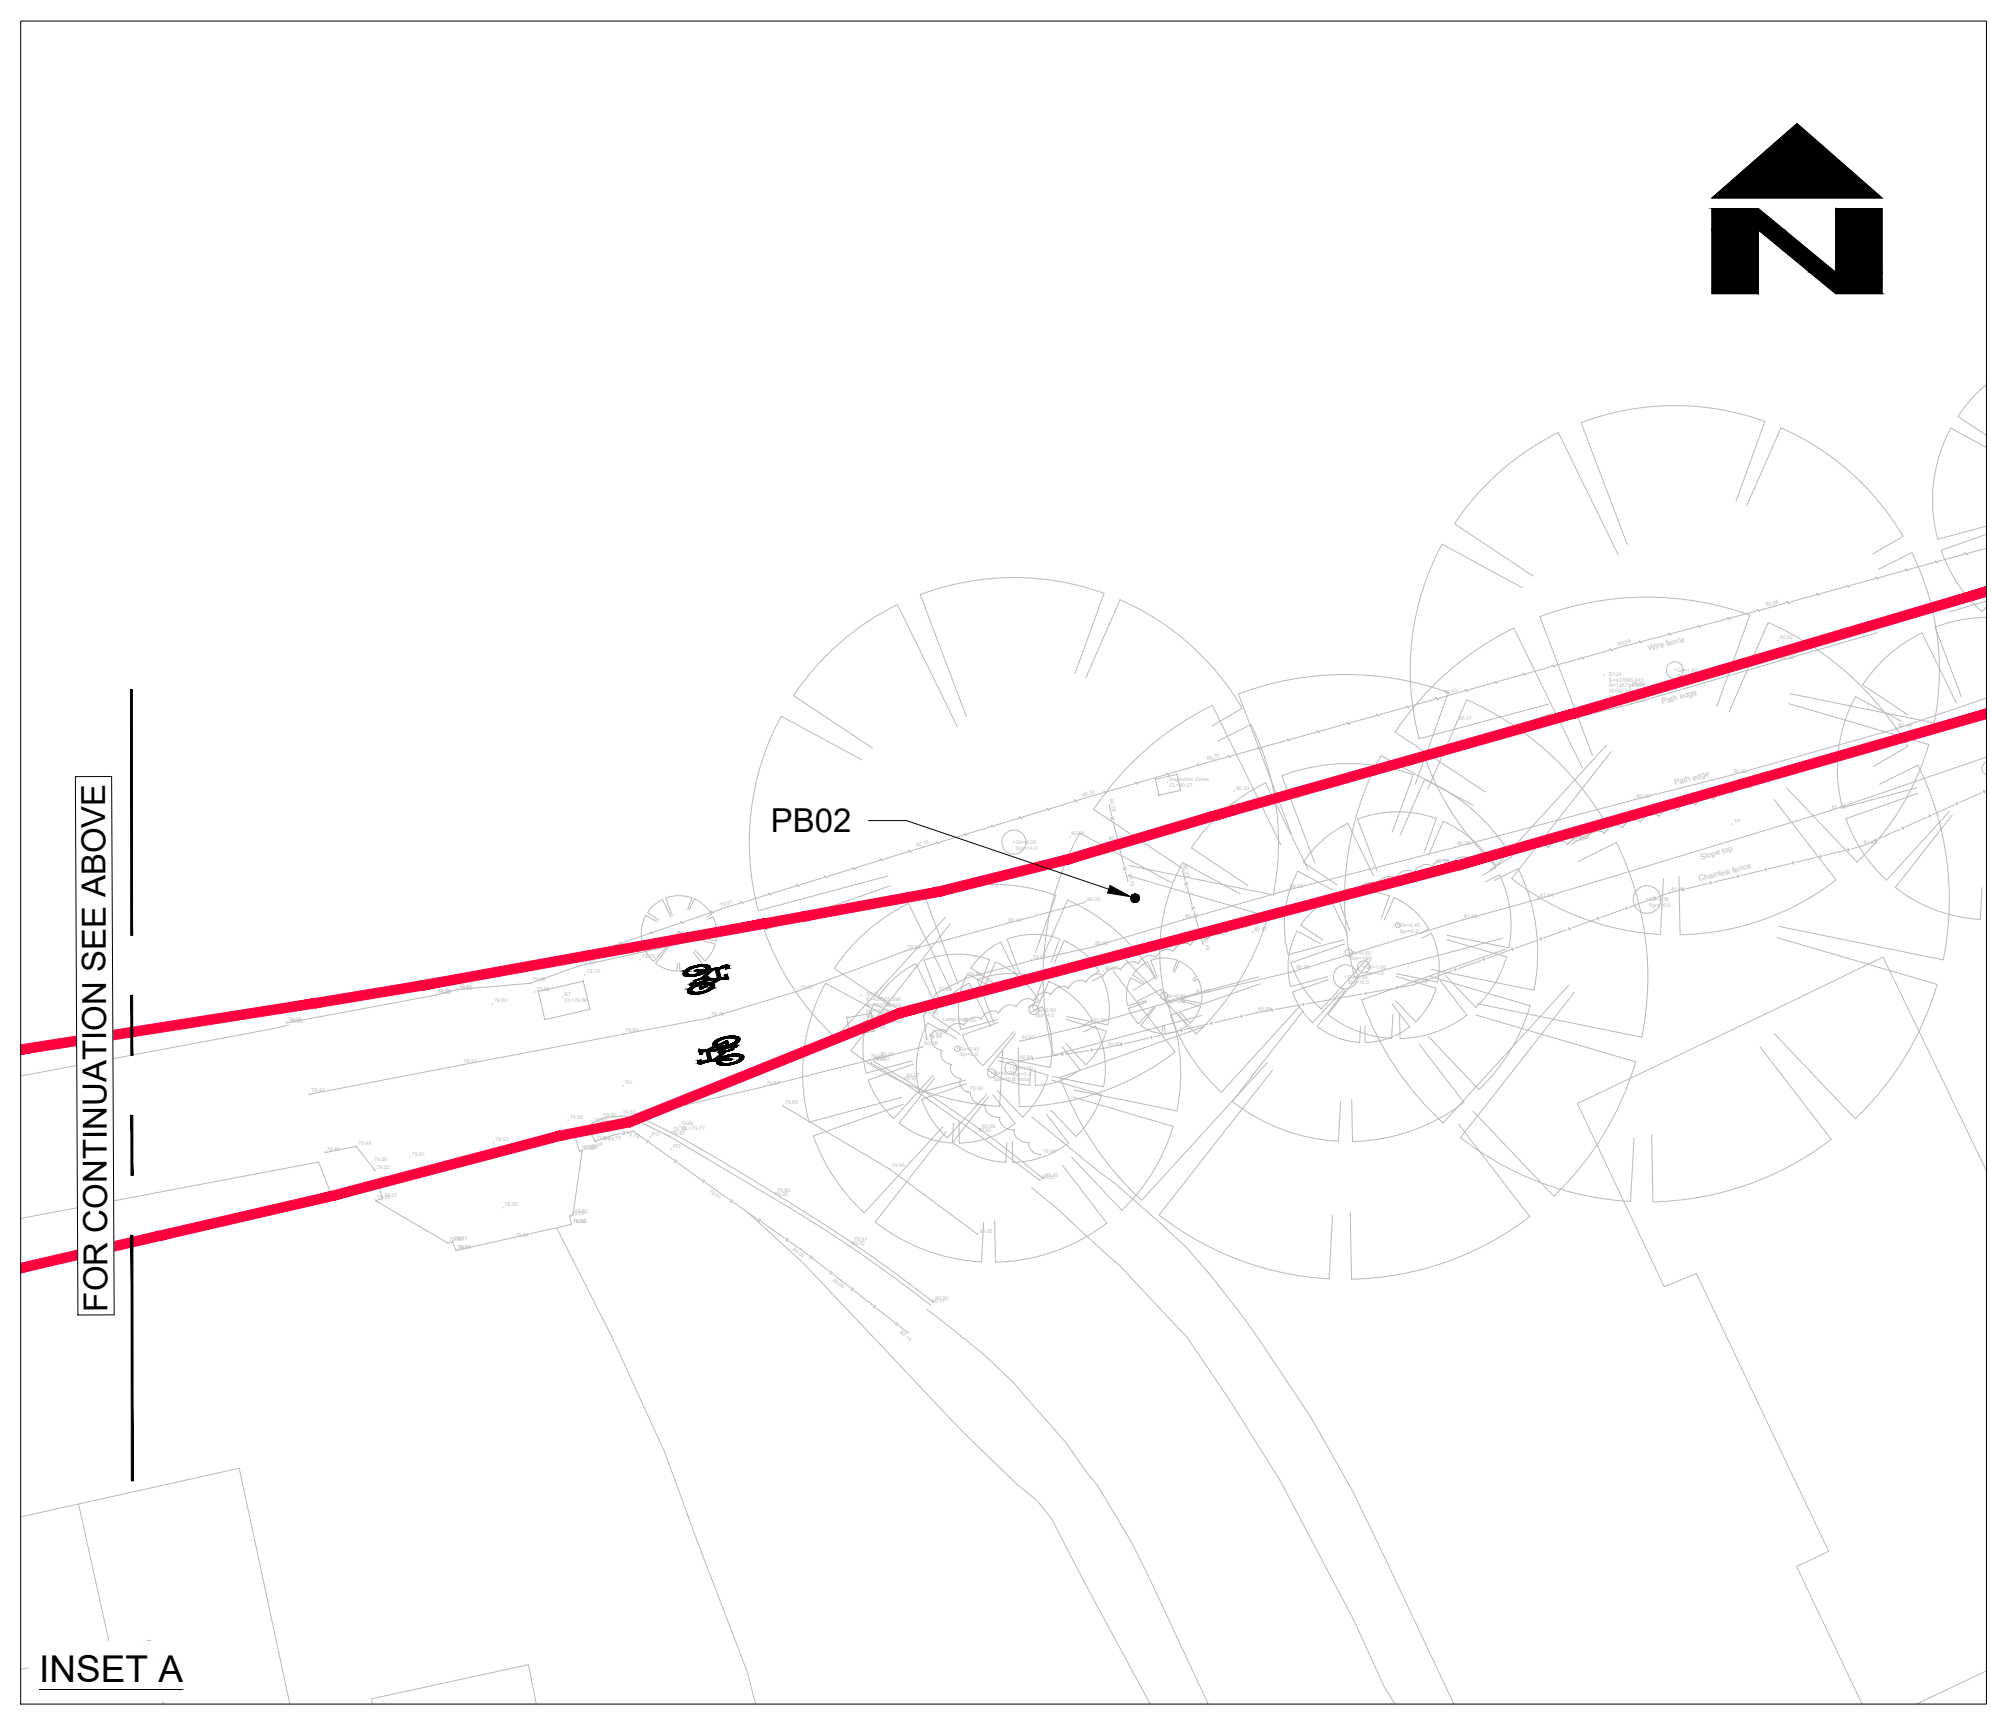

© CROWN COPYRIGHT AND DATABASE RIGHTS 2026
ORDNANCE SURVEY 100019180

SUIT	REV	PURPOSE OF ISSUE AND DESCRIPTION OF AMENDMENTS	DATE	DESIGNER	CAD	CHKD	APPD
D2	P01	FOR TENDER	25.06.2026	SM	DJR	CJC	ARW

CLIENT

HAMPSHIRE COUNTY COUNCIL
UNIVERSAL SERVICES DIRECTORATE
TRANSPORT IMPLEMENTATION

CONSULTANT

Hampshire County Council
Engineering Services

TIM LAWTON BEng CEng FICE FCIHT : ASSISTANT DIRECTOR OF UNIVERSAL SERVICES

HORIZONTAL SCALE @ A1 1:200	SCHEME EASTERN ANDOVER ACTIVE TRAVEL IMPROVEMENTS PHASE 1	DRAWING TITLE GENERAL ARRANGEMENT
VERTICAL SCALE @ A1 N/A		
SHEET NUMBER 1 OF 2	JOB No. C.J009684.01	HCC CAD PLOT: 25/6/2026 8:22:02
CJ009684 -HEH-HGN-15739368-DR-CH-0002		SUIT REV D2 P01